
 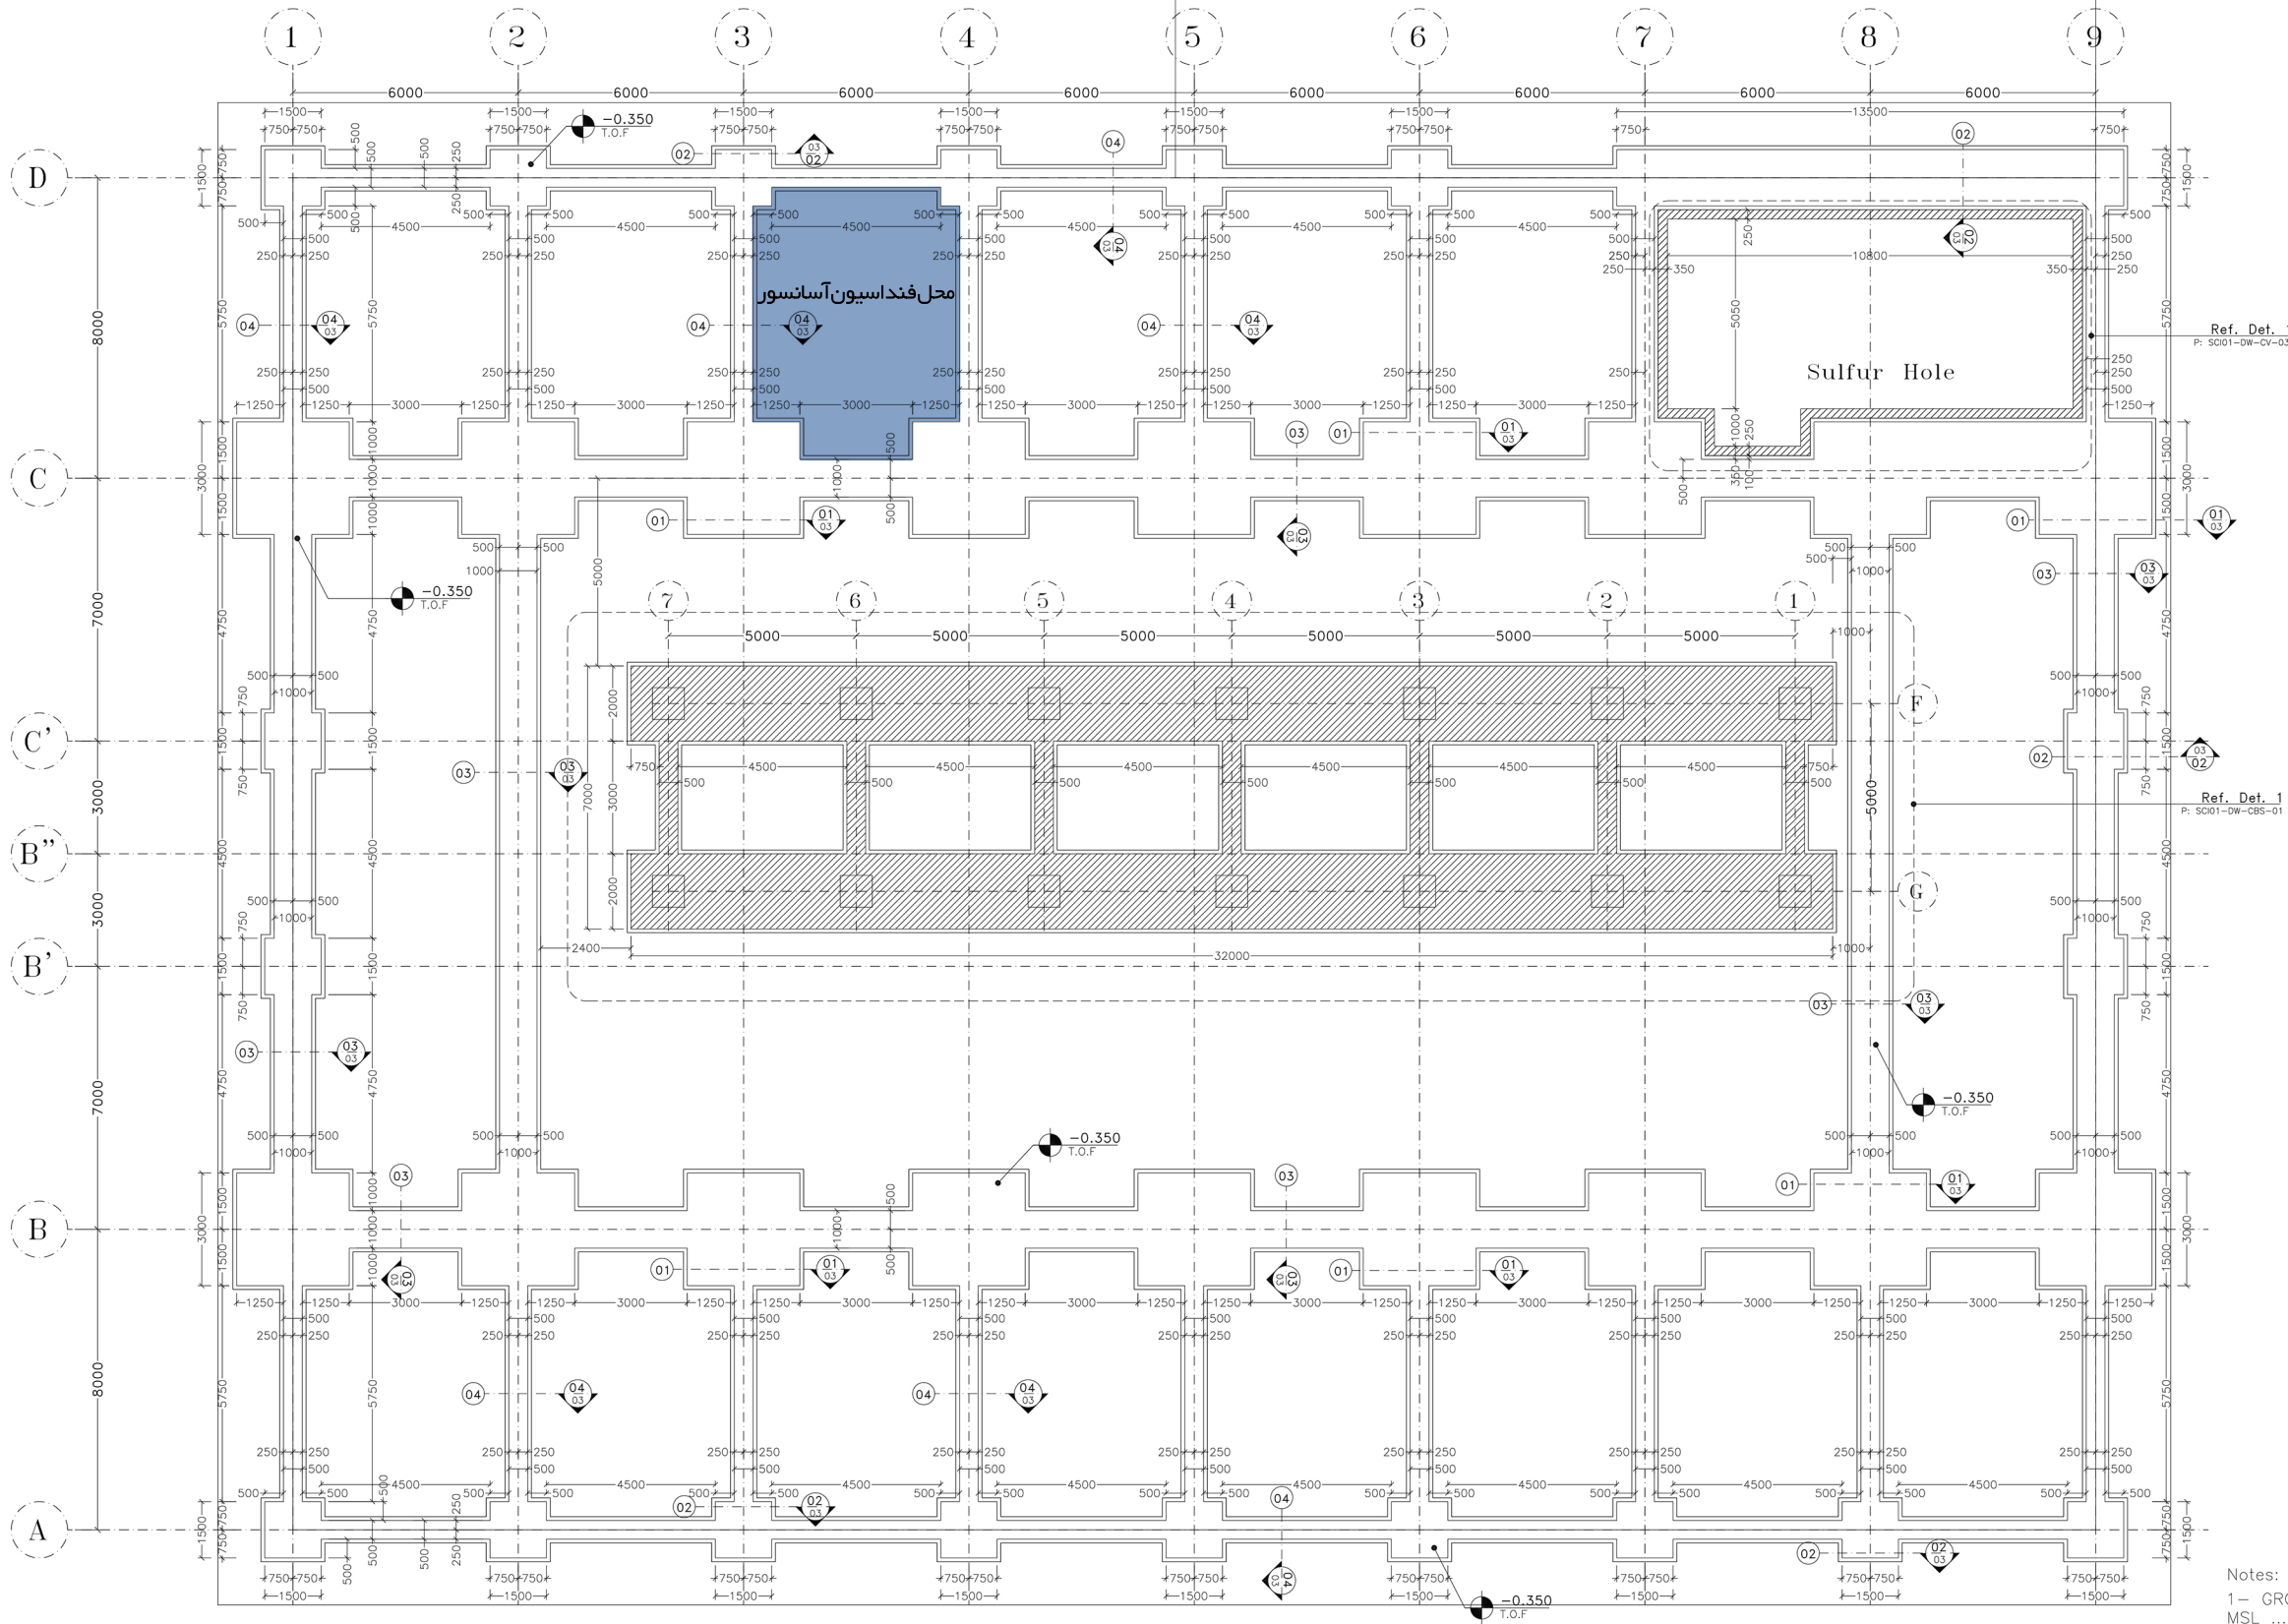


Confidential: This document discloses proprietary information. It may not be reproduced nor disclosed any person not used for any purpose, except with the written permission of Pars Bonyan Co.



Foundation Plan

Sc: 1/100

Notes:
1- GROUND LEVEL (= GL ± 0.00) IS EQUAL TO MSL

Employer: Sarcheshmeh Copper Investment Co.			Consultant: Pars Bonyan Consulting Engineers	
Contractor: Kimia Neshan Kerman Sabz			DWG Title:	
Project Title: SCI Industrial Chemical Complex Co.		Foundation Plan		
Designed By:	CV Depart.	DWG Type:		Size: A1
Prepared By:	CV Depart.	Civil		Scale: As Shown
Checked By:	M.J.Mohi	DWG No.:		Rev.: 00
Approved By:	M.J.Mohi	SCI01-DW-CV-02		Sheet: 1/3

Rev.:	Date	Purpose	Prepared By	Checked By	Approved By
01	Sep. 2017	FA	CV Depart.	M.J.Mohiti	M.J.Mohiti